



FRONT ELEVATION
SCALE: 1/4" = 1'-0"

The Cityscape-2 Plan


Address	
Addition	
Block	
Lot	

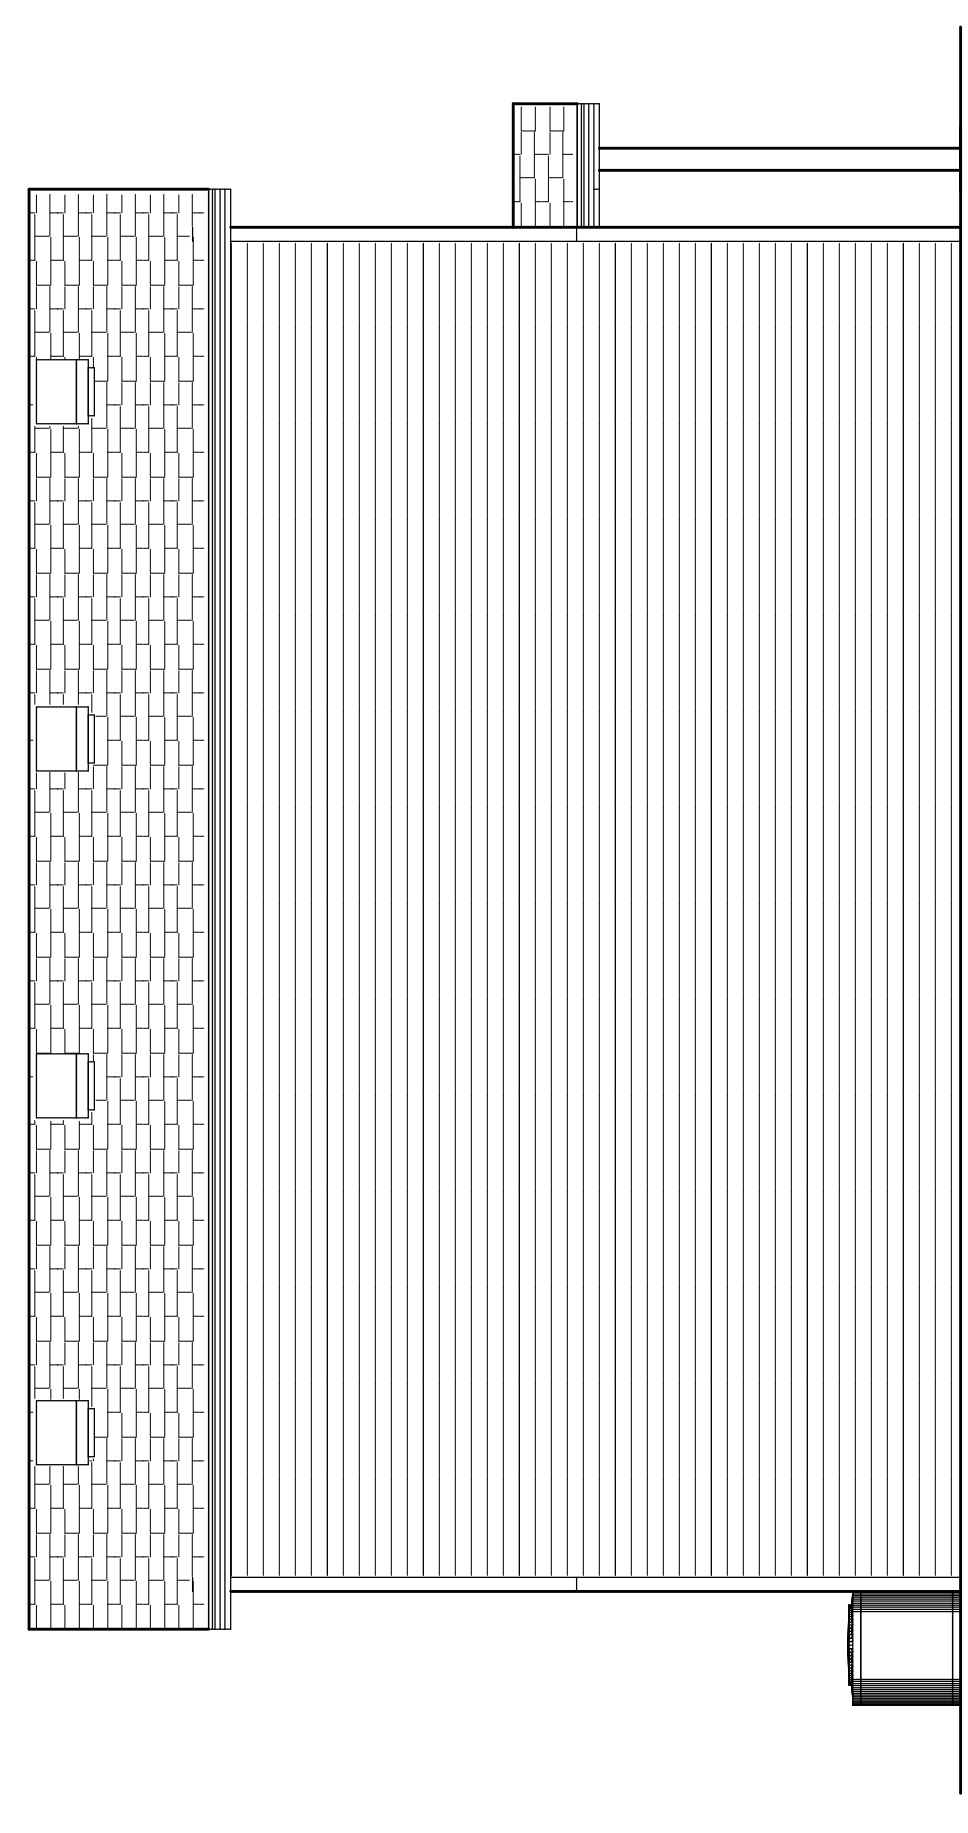


RIGHT ELEVATION
SCALE: 1/4" = 1'-0"

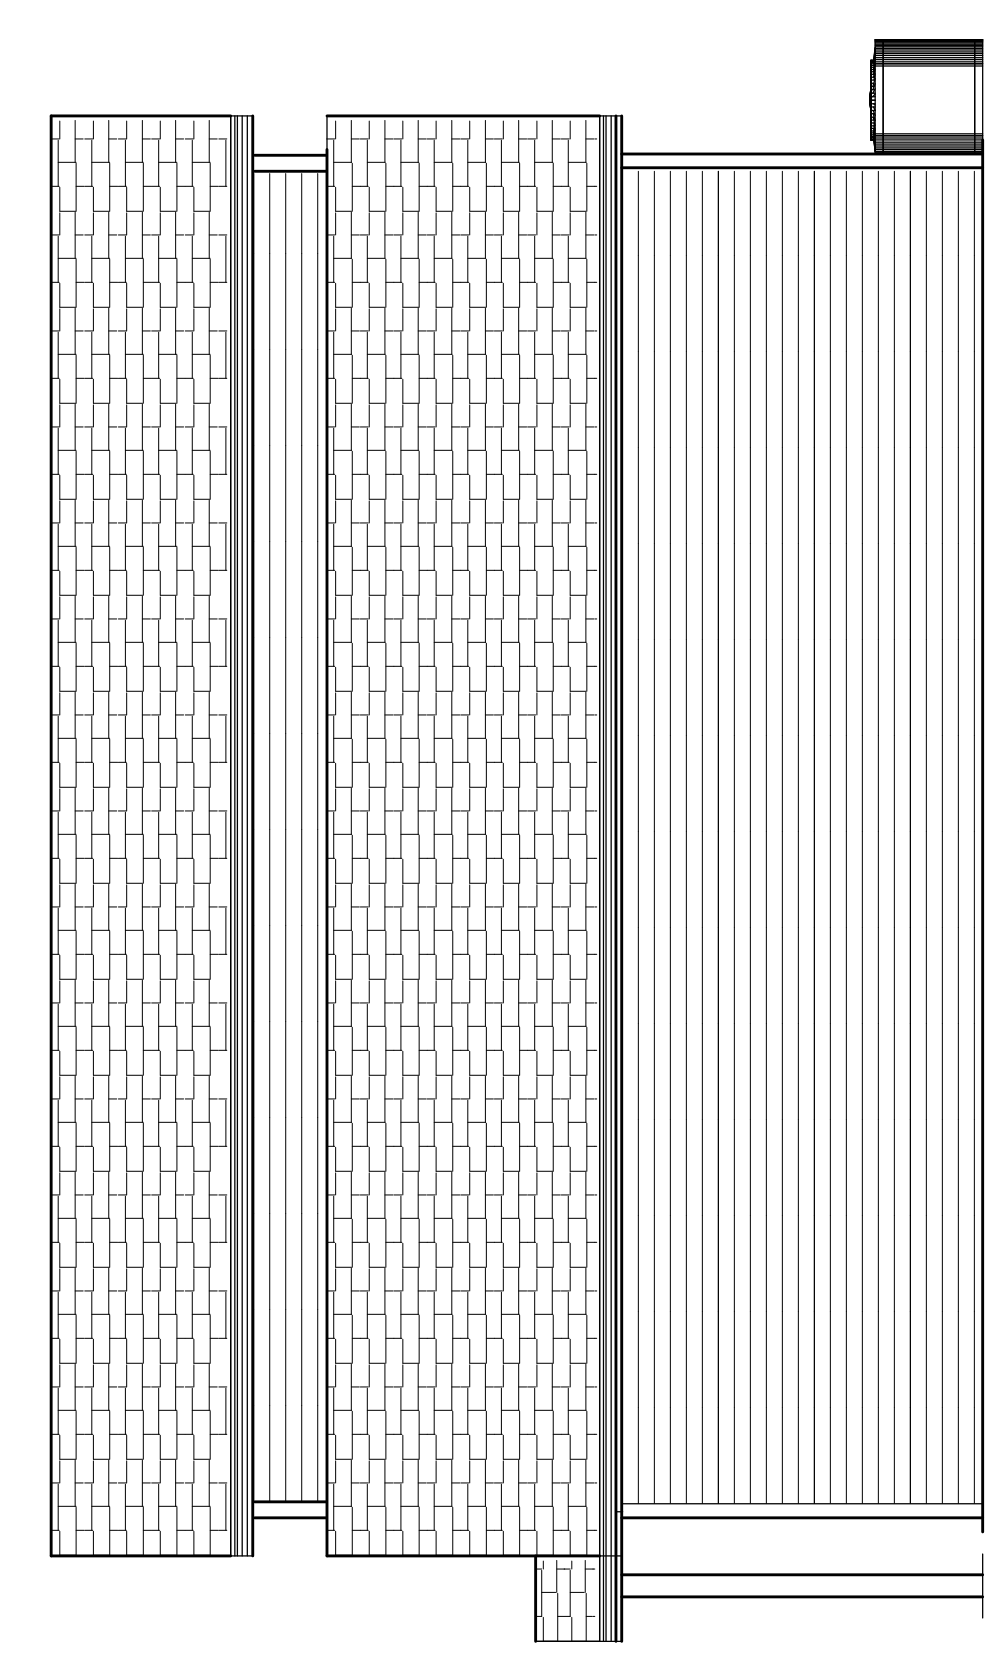


LEFT ELEVATION
SCALE: 1/4" = 1'-0"

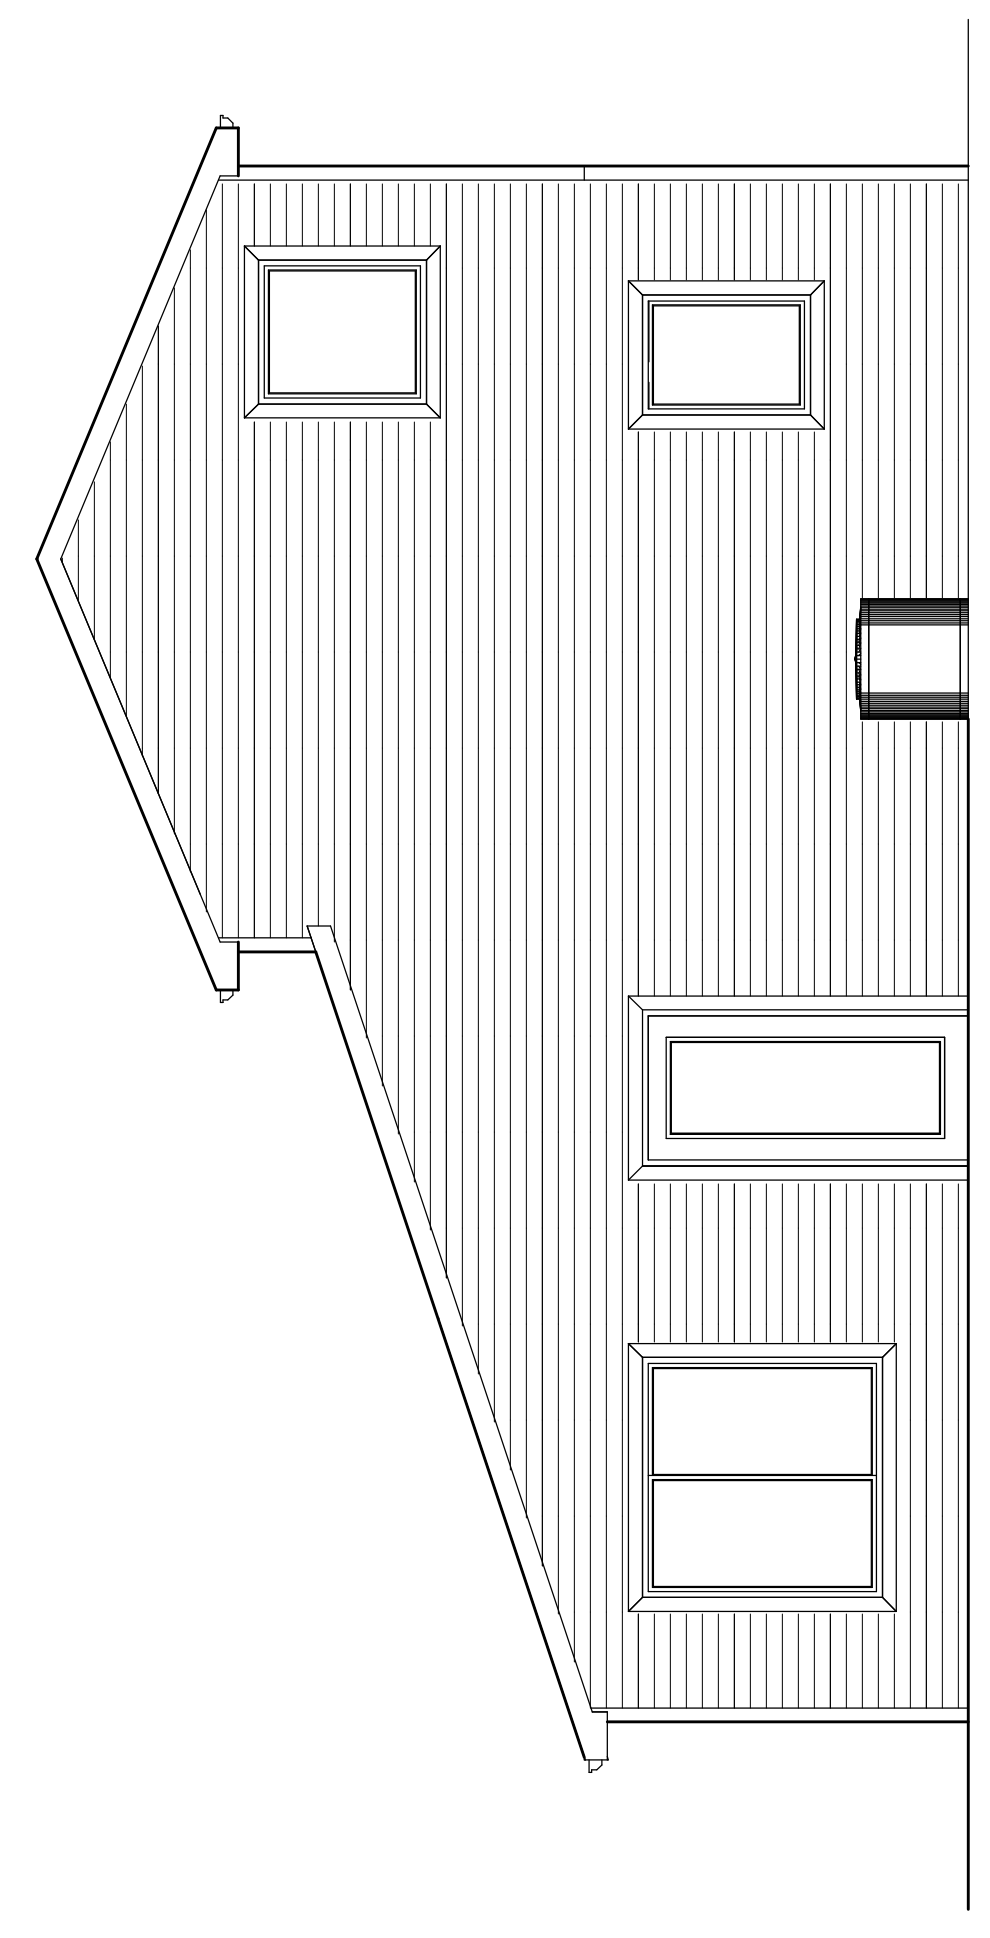


REAR ELEVATION
SCALE: 1/4" = 1'-0"

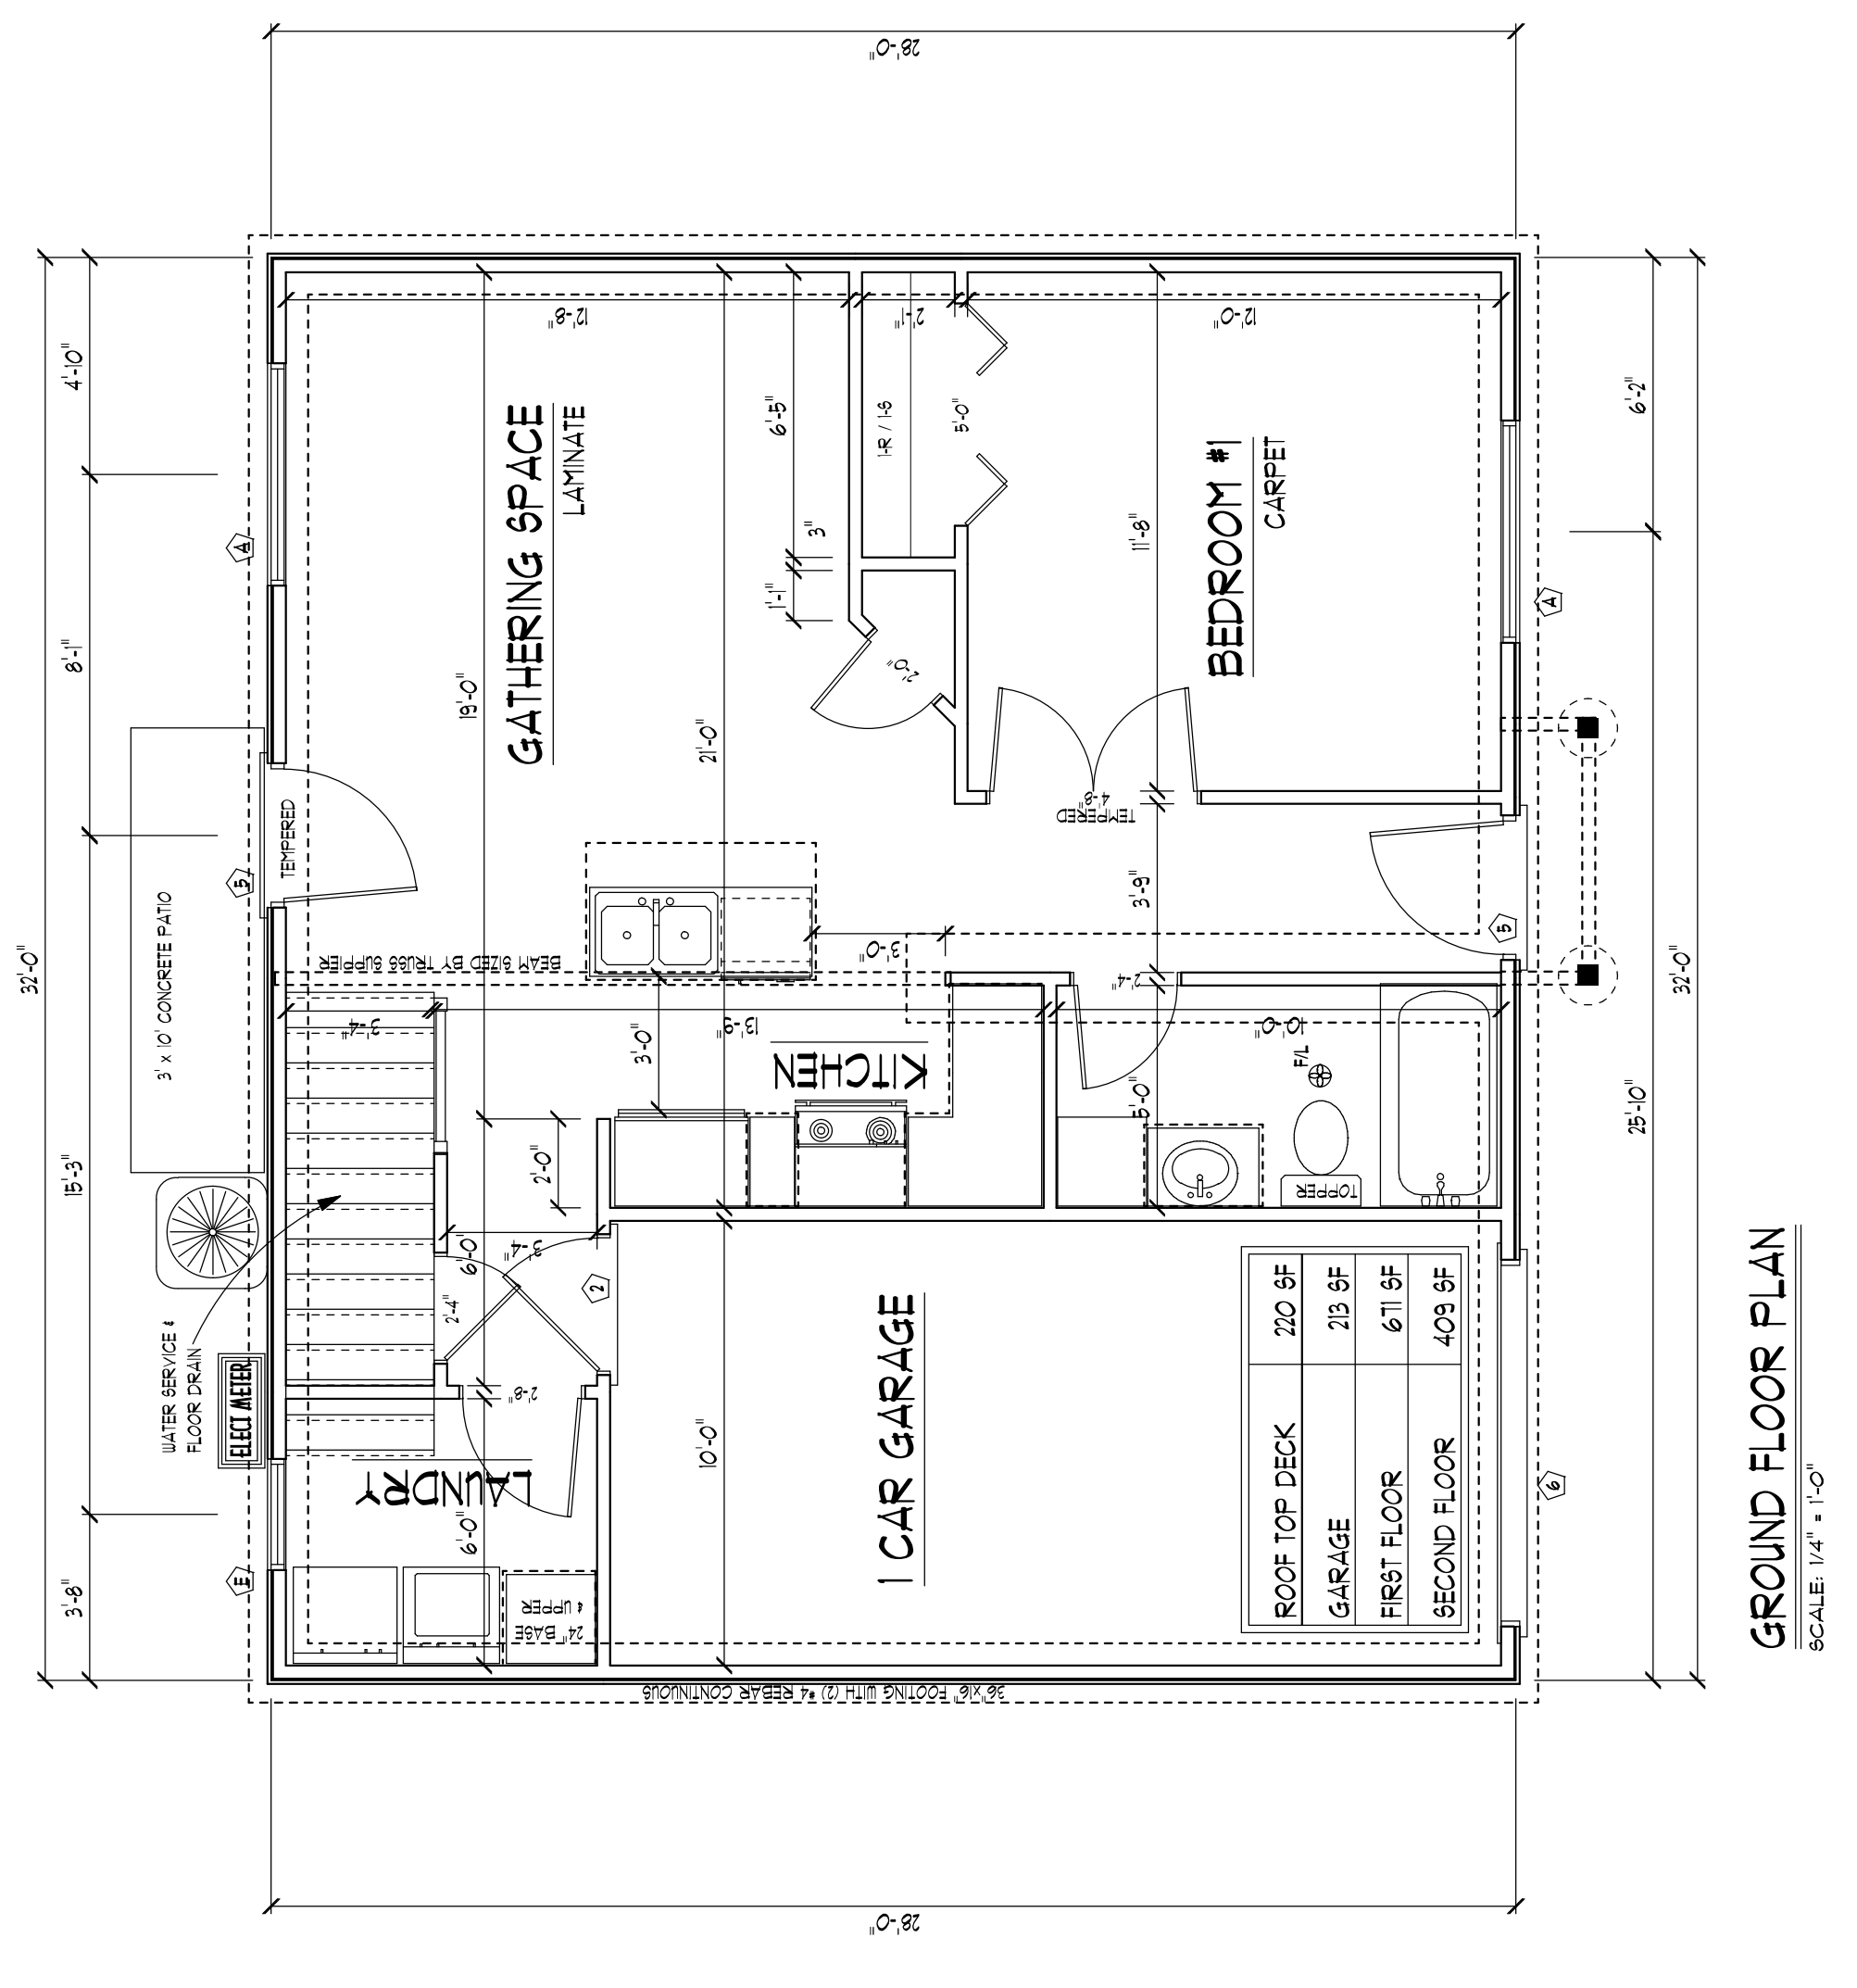


GROUND FLOOR PLAN
SCALE: 1/4" = 1'-0"

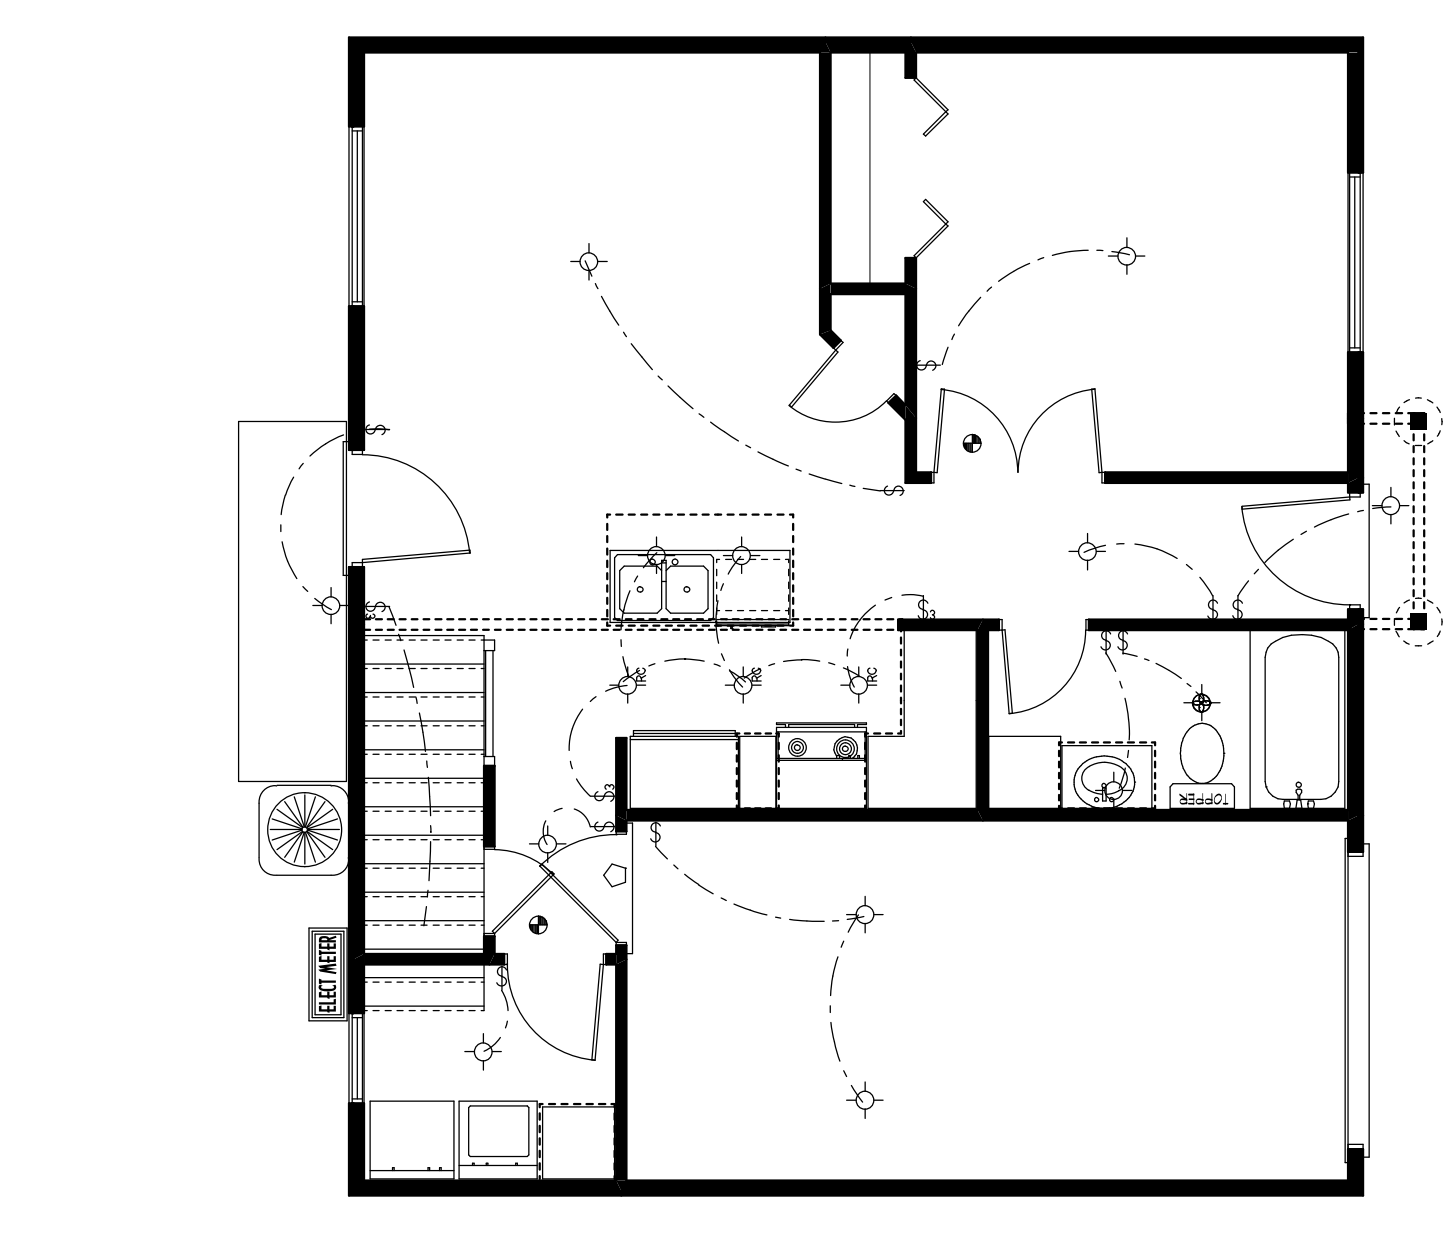

GROUND FLOOR ELECTRICAL PLAN

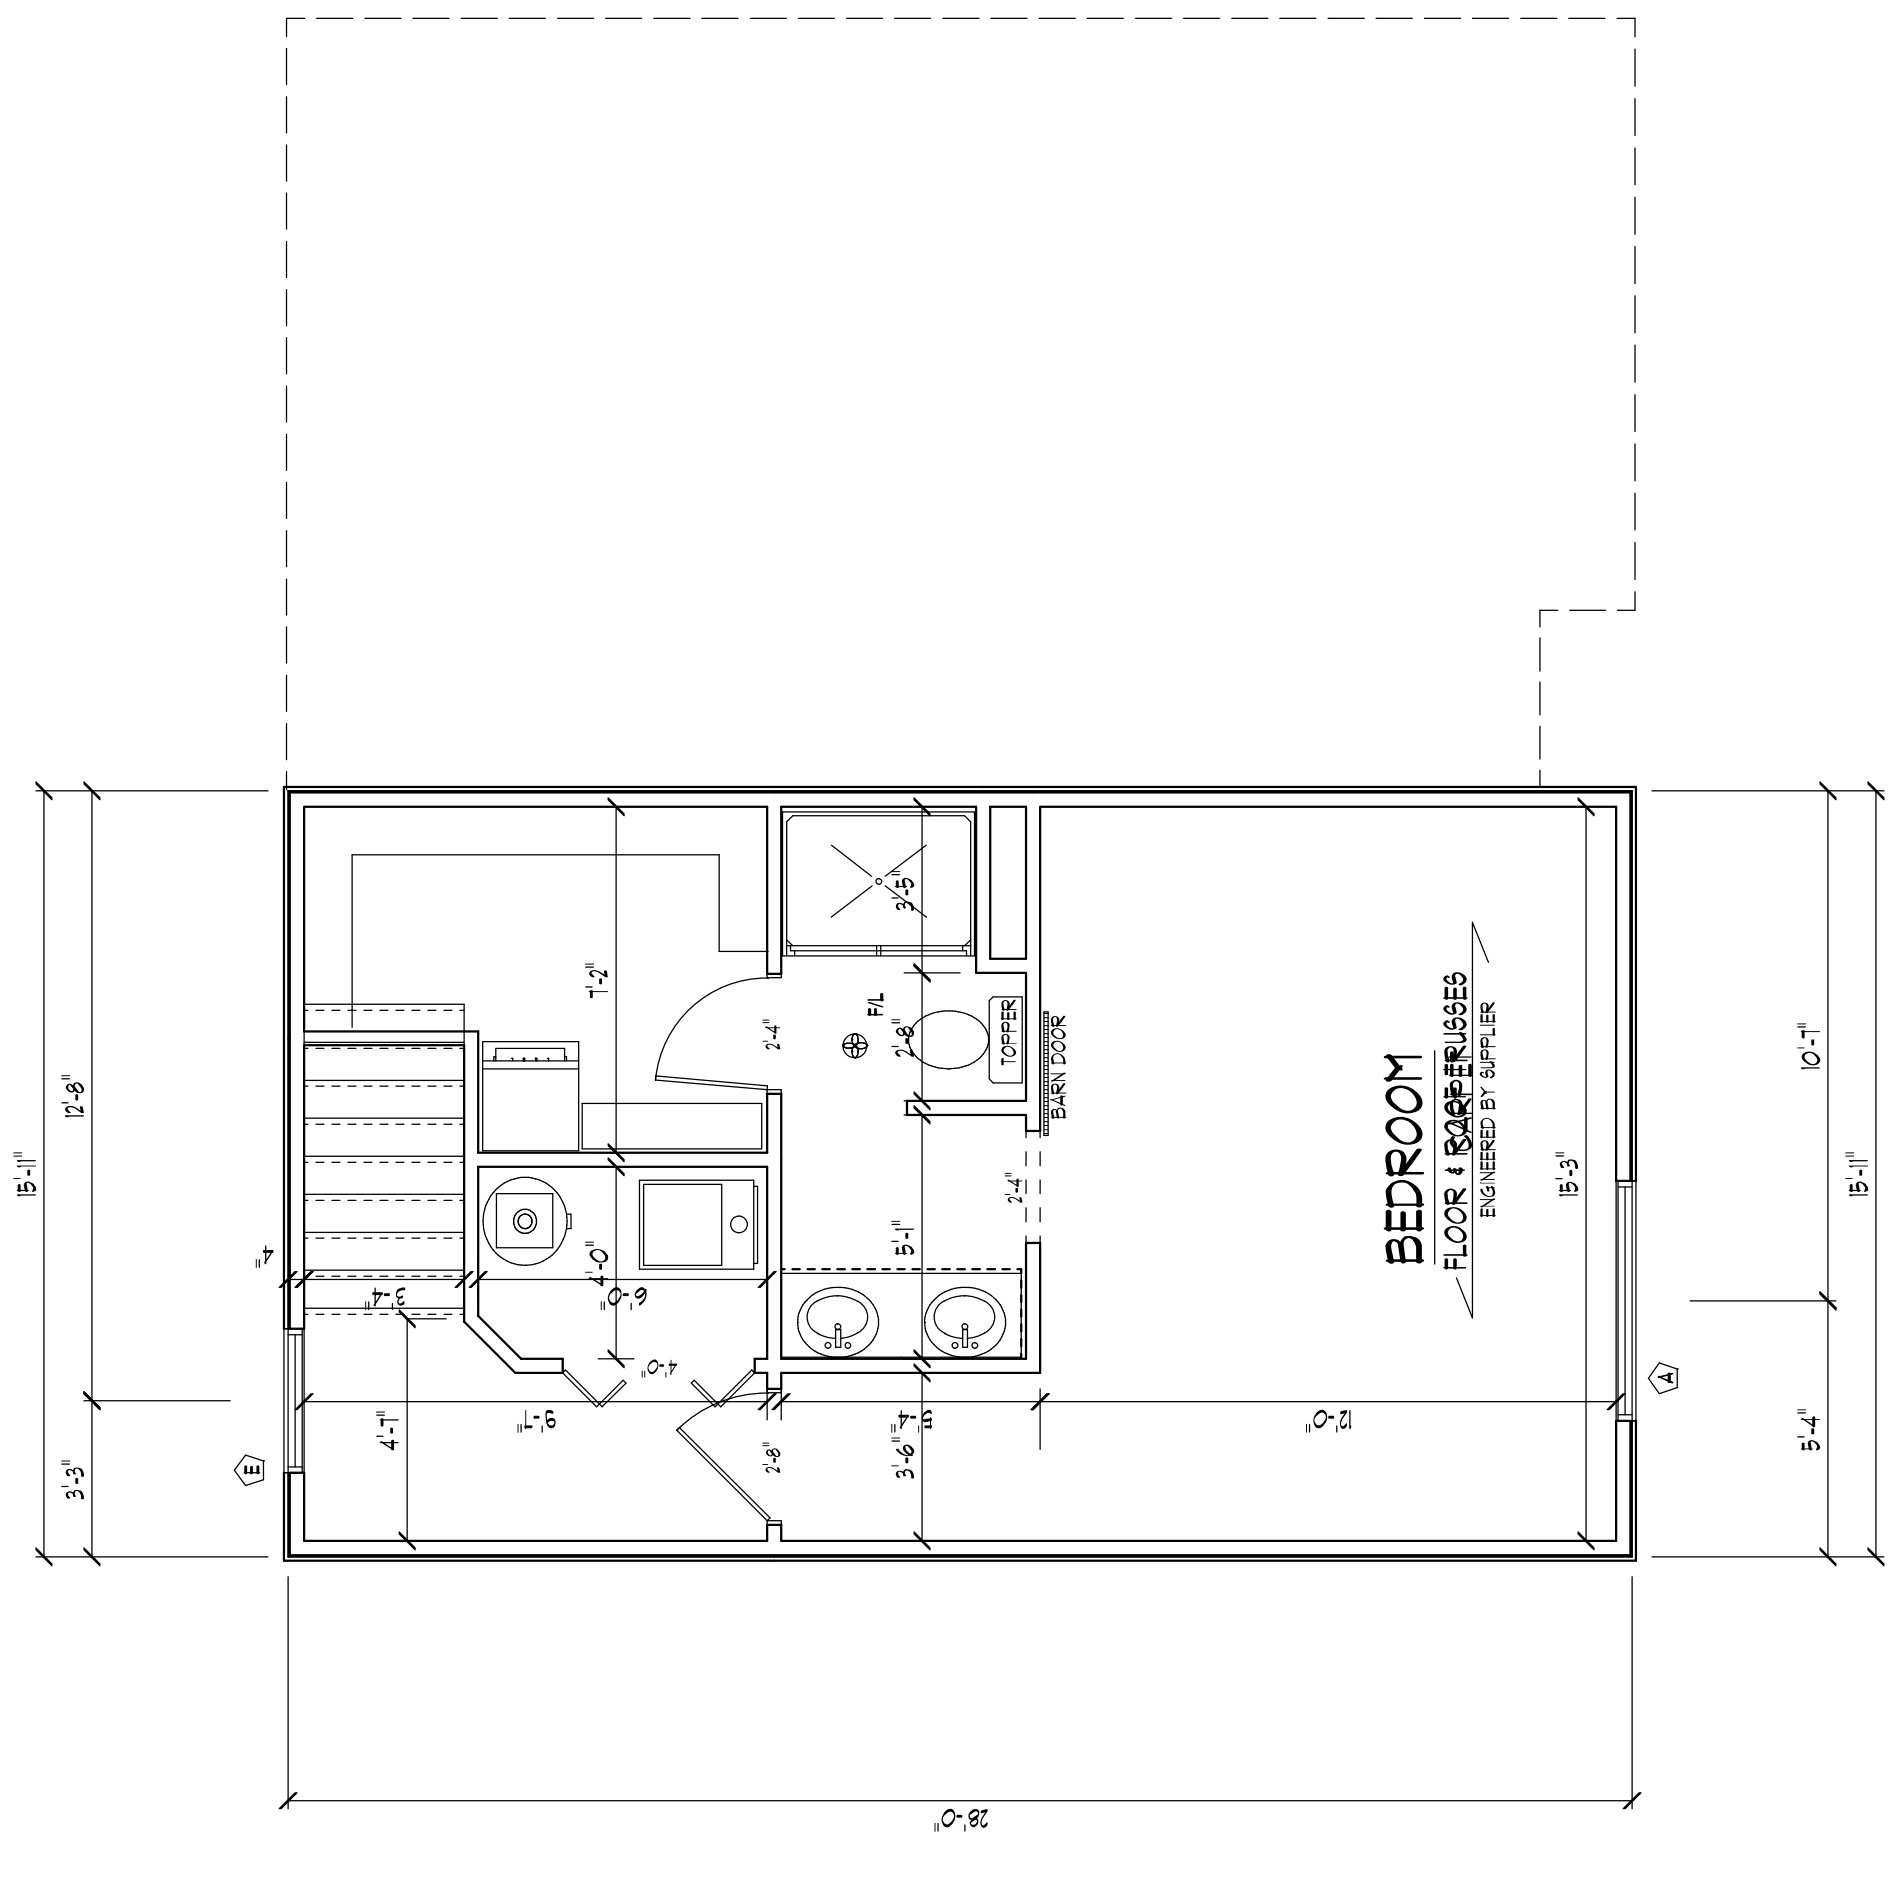

UPPER FLOOR PLAN
SCALE: 1/4" = 1'-0"

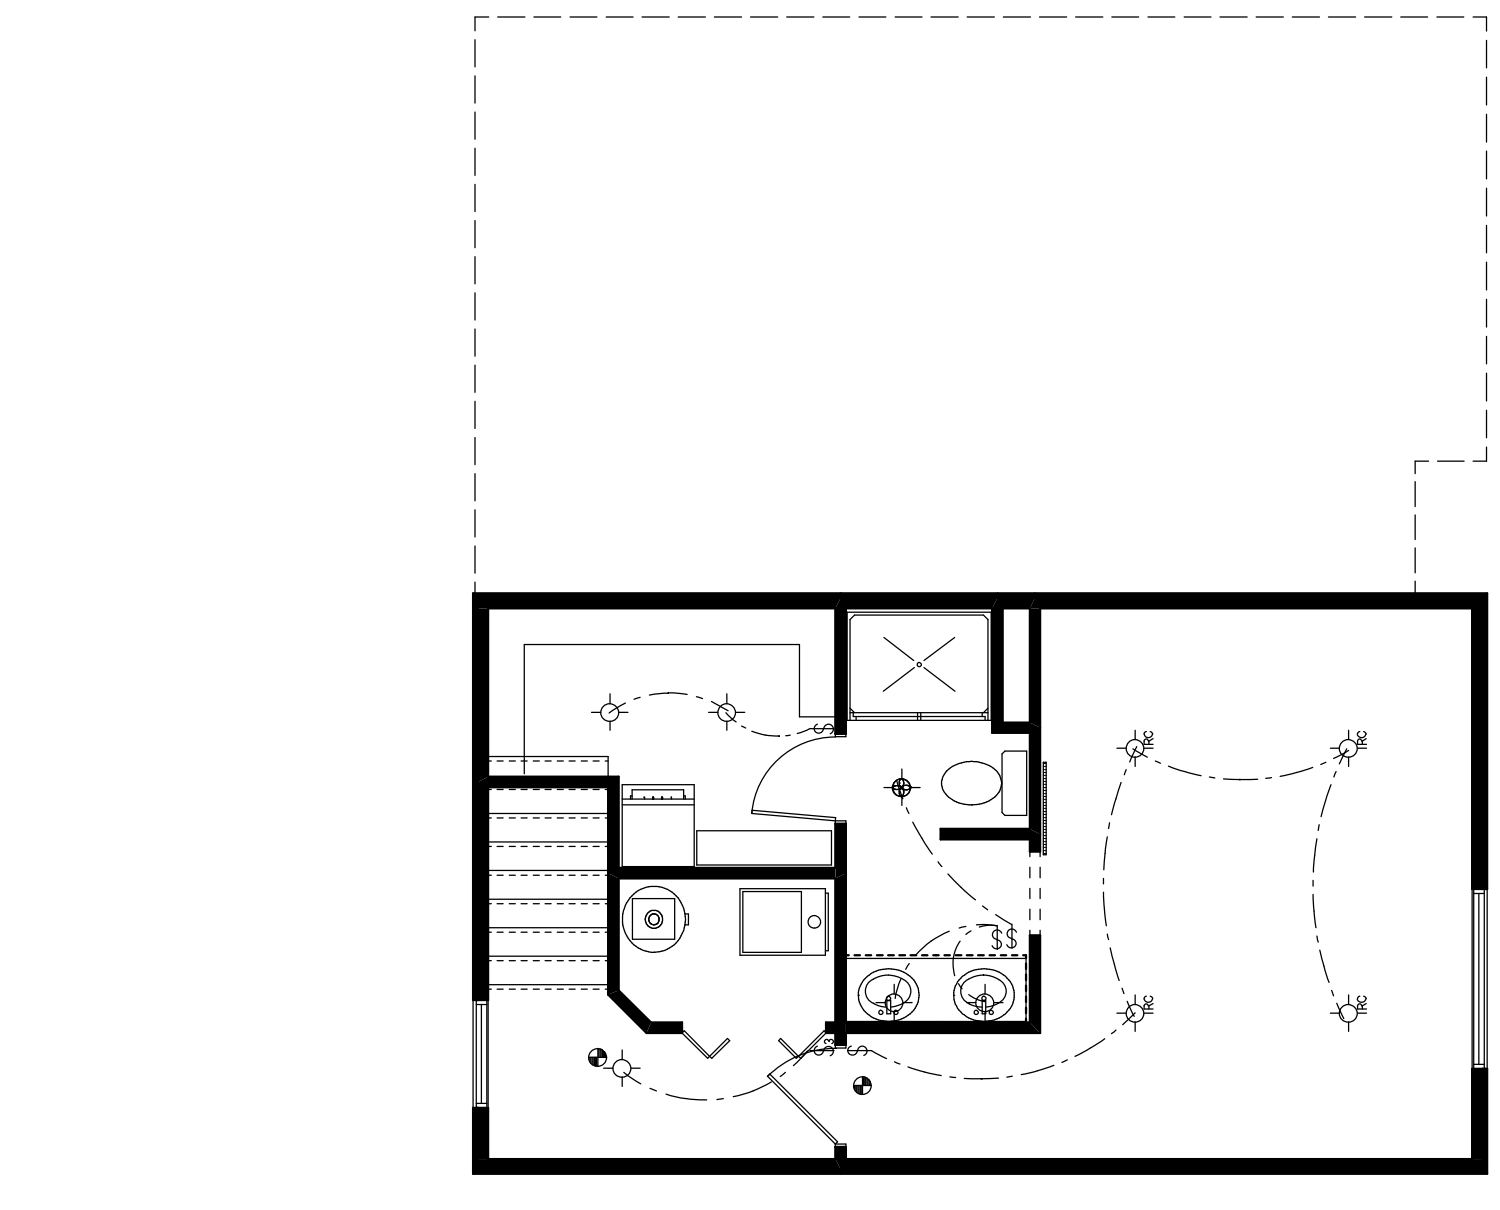

UPPER FLOOR ELECTRICAL PLAN

